


CONDENSATE PIPING PLAN - MECHANICAL
SCALE: 3/32" = 1'-0"

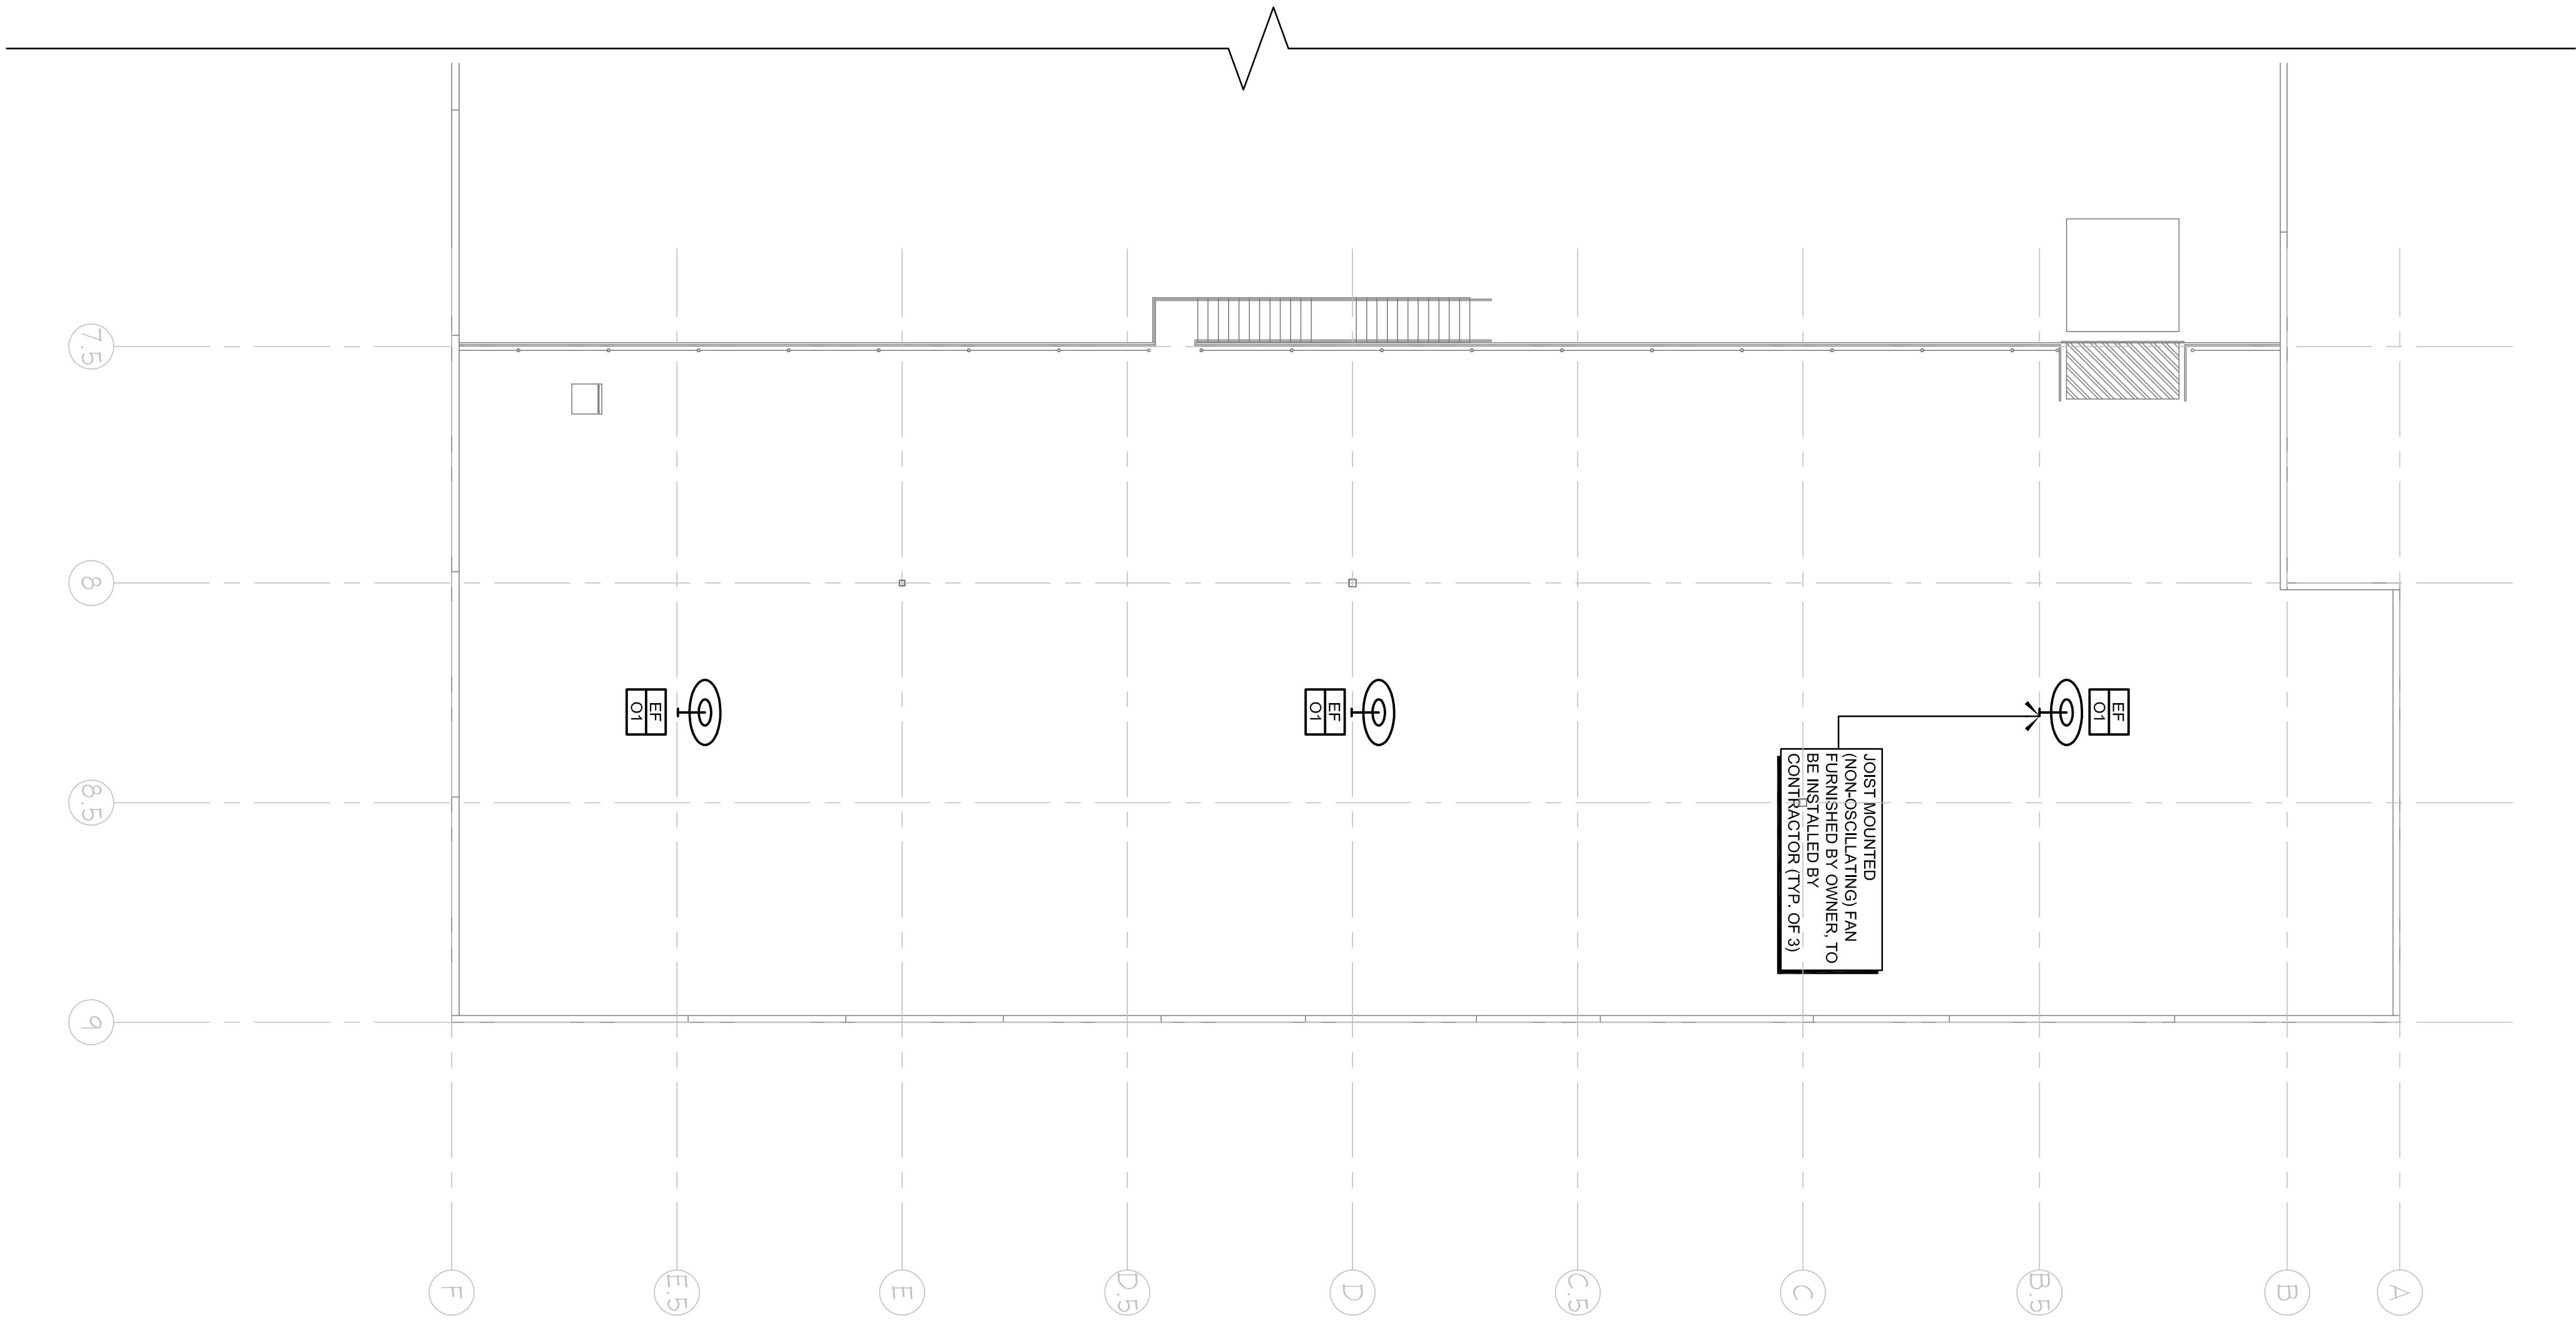

MEZZANINE PLAN - MECHANICAL
SCALE: 3/32" = 1'-0"

DRAWING TITLE :

**MEZZANINE & PIPING PLAN
- MECHANICAL**

PROJECT TITLE :

**Victor Distributing Company
NEW DISTRIBUTION CENTER
FORT MEYERS, FLORIDA**

Advanced Systems Engineering, Inc.

Project Engineer: David S. Bess (FE-51871)
Manager: JLB (CADD)

Job No. 14027.01
Manager: JLB
CADD: JLB

15000 Automobile Boulevard, Suite 200, Clearwater, FL 33762 • Office: 727.240.8196 • Fax: 727.240.8415
Copyright © 2011 - All rights reserved. No part of this document may be reproduced without the permission of ASE.

REVISIONS	
1	
2	
3	
4	
5	

STATE OF FLORIDA
PROFESSIONAL ENGINEER
No. 61871
DAVID S. BESS

I CERTIFY TO THE BEST OF MY KNOWLEDGE AND BELIEF THAT THE ENGINEER HAS COMPLIED WITH THE APPLICABLE CODES, RULES AND REGULATIONS OF THE BOARD OF PROFESSIONAL ENGINEERS AND ARCHITECTS OF THE STATE OF FLORIDA.

JOB NO.: 14027.07
DRAWN BY: JLB
ISSUE DATE: 09.16.14

SHEET NUMBER
M3